

GENERAL NOTES:

- A. REFER TO PROJECT MANUAL FOR ADDITIONAL REQUIREMENTS.
- B. REFER TO PRE-ENGINEERED METAL BUILDING DRAWINGS FOR ADDITIONAL REQUIREMENTS.
- C. REFER TO MECHANICAL / ELECTRICAL PLAN FOR SYSTEM TYPES AND LOCATIONS.
- D. REFER TO SITE DEVELOPMENT PLANS FOR ADDITIONAL REQUIREMENTS.

KEY NOTES:

- 1 EXTERIOR INSULATION AND FINISH SYSTEM (E.I.F.S.): REFER TO EXTERIOR FINISH SCHEDULE.
- 1A EXTERIOR INSULATION AND FINISH SYSTEM (E.I.F.S.) ACCENT BAND: REFER TO FINISH SCHEDULE AND WALL SECTIONS.
- 2 MASONRY WALL CONSTRUCTION (ACCENT): REFER TO EXTERIOR FINISH SCHEDULE AND WALL SECTIONS.
- 2A MASONRY WALL CONSTRUCTION (FIELD): REFER TO EXTERIOR FINISH SCHEDULE AND WALL SECTIONS.
- 3 PRE-ENGINEERED METAL BUILDING SHEET METAL STANDING SEAM ROOF (BEYOND): BY PRE-ENGINEERED METAL BUILDING COMPANY.
- 4 PRE - FINISHED METAL CAP FLASHING: REFER TO EXTERIOR FINISH SCHEDULE.
- 5 PRE - ENGINEERED METAL CAP FLASHING: (AT EIFS) COLOR SHALL BE FIELD PAINTED SW 6871 POSITIVE RED.
- 6 PRE - ENGINEERED METAL BUILDING INTERNAL GUTTER AND THROUGH WALL SCUPPER SYSTEM: PRE - FINISHED, COLOR SHALL MATCH MASONRY FIELD COLOR.
- 7 CONCRETE MASONRY UNIT (CMU): SPLIT FACE HEAD AND JAMB UNITS.
- 8 LINE OF ROOF: DASHED LINE INDICATES LINE OF ROOF BEYOND WITH SLOPE OF 1/4" PER FOOT.
- 9 SIGN: APPROXIMATE OUTLINE OF SIGN. PROVIDE BLOCKING AS REQUIRED FOR MOUNTING OF SIGN, COORDINATE WITH SIGN COMPANY FOR EXACT SIGN PLACEMENT. OWNER FURNISHED AND INSTALLED LOGO. REFER TO SIGN PACKET INFORMATION FOR FURTHER DETAIL.
- 10 ADDRESS NUMBERS: 6" VINYL BY CONTRACTOR. COLOR TO BE WHITE.
- 11 NOT USED
- 12 DOOR AND FRAME: FIELD PAINT (REFER TO EXTERIOR FINISH SCHEDULE.)
- 13 STOREFRONT: (REFER TO FLOOR PLAN FOR WINDOW TYPES.)
- 14 LINE OF FOUNDATION: (REFER TO FOUNDATION PLAN.)
- 15 STEEL BOLLARDS: (9 ) TYPICAL AT STOREFRONT ( 2 ) AT O.H. DOOR LOCATION. (REFER TO EXTERIOR FINISH SCHEDULE AND FOUNDATION PLAN.)
- 16 HOSE BIB: (REFER TO PLUMBING PLAN)
- 17 LIGHT FIXTURE: (REFER TO ELECTRICAL PLAN)
- 18 (NOT USED)
- 19 ROOF TOP UNIT (BEYOND): APPROXIMATE LOCATION (REFER TO MECHANICAL PLAN FOR EXACT LOCATION)
- 20 MECHANICAL WALL PENETRATIONS: PROVIDE FRAMING, FLASHING, AND SEALANT AS REQUIRED. (REFER TO M.E.P. SHEETS)
- 21 ROOF PIPING VENT(BEYOND): REFER TO DETAIL 5/A3.
- 22 PRE-FABRICATED METAL CANOPY SYSTEM: ANCHORED TO STRUCTURAL SYSTEM PER MANUFACTURER'S RECOMMENDATIONS. REFER TO WALL SECTIONS AND STRUCTURAL DRAWINGS. COORDINATE ROD LOCATIONS WITH SIGNAGE.
- 23 MASONRY CONTROL / EXPANSION JOINT: (MATCH MASONRY) PROVIDE SEALANT OVER 1/2" DIAMETER FOAM BACKER ROD. REFER TO STRUCTURAL DRAWINGS.
- 24 RUSTICATION JOINT: REFER TO DETAIL 6/A3.
- 25 PRE - FINISHED SHEET CONDUCTOR HEAD AND DOWNSPOUT SYSTEM: PRE - FINISHED, COLOR SHALL MATCH MASONRY FIELD COLOR.

O'Reilly AUTO PARTS

CORPORATE OFFICES  
233 SOUTH PATTERSON  
SPRINGFIELD, MISSOURI 65802  
(417) 862-2674 TELEPHONE





PROJECT:  
NEW O'REILLY AUTO PARTS STORE  
403 AGLER ROAD  
GAHANNA, OHIO

EXTERIOR ELEVATIONS

Buddy D. Webb  
Architect - Consultant  
3057 EAST CAIRO  
SPRINGFIELD, MISSOURI 65802  
(417) 877-1385 TELEPHONE  
(417) 877-9736 FAX

DRAWN BY: EN LG, BDW  
CHECKED BY:  
DATE: 06/04/15  
REVISION: A1 AD. NO. 1 (09/04/15)  
PROJECT NUMBER: GH1  
SHEET NUMBER

A3

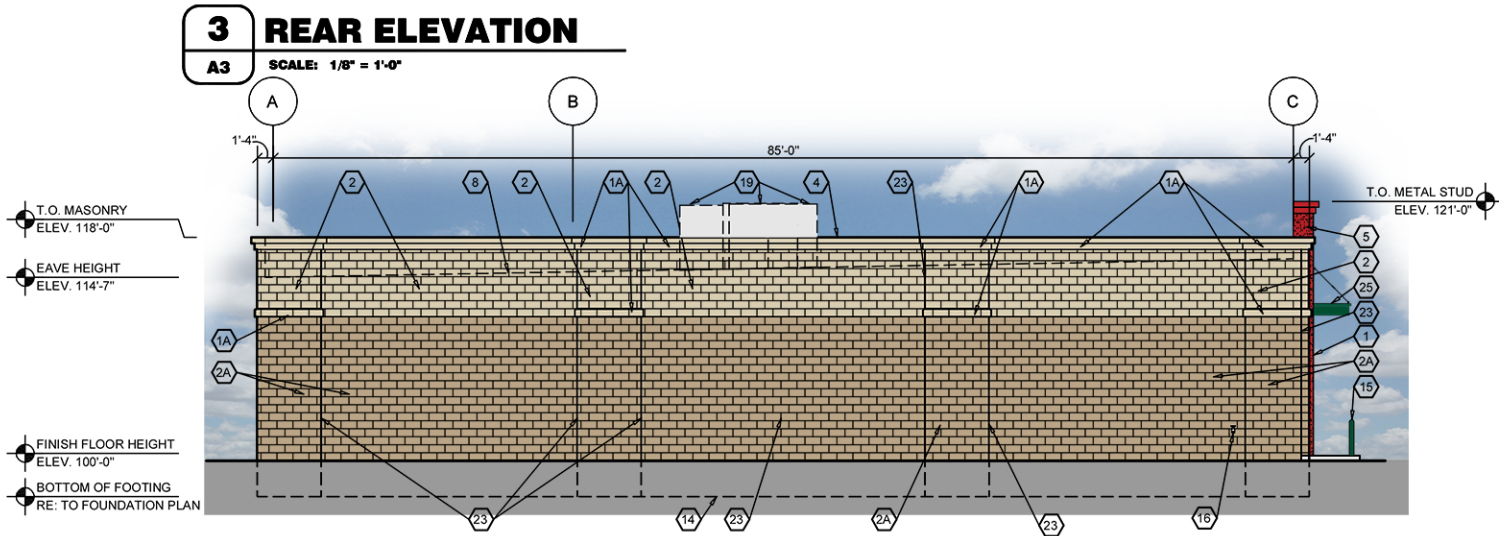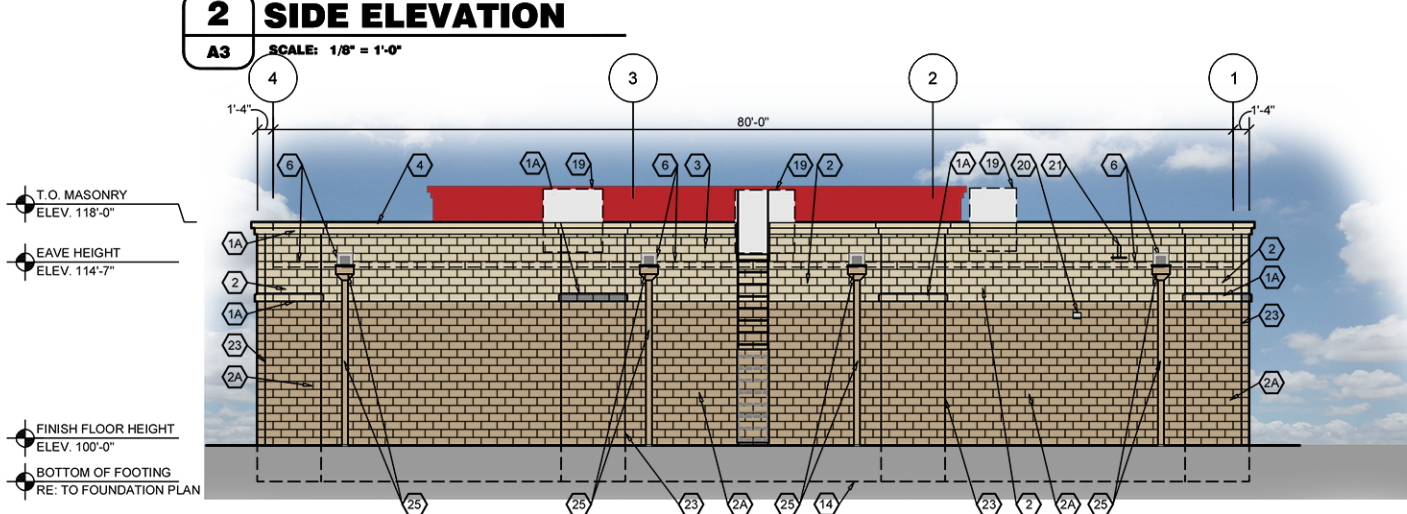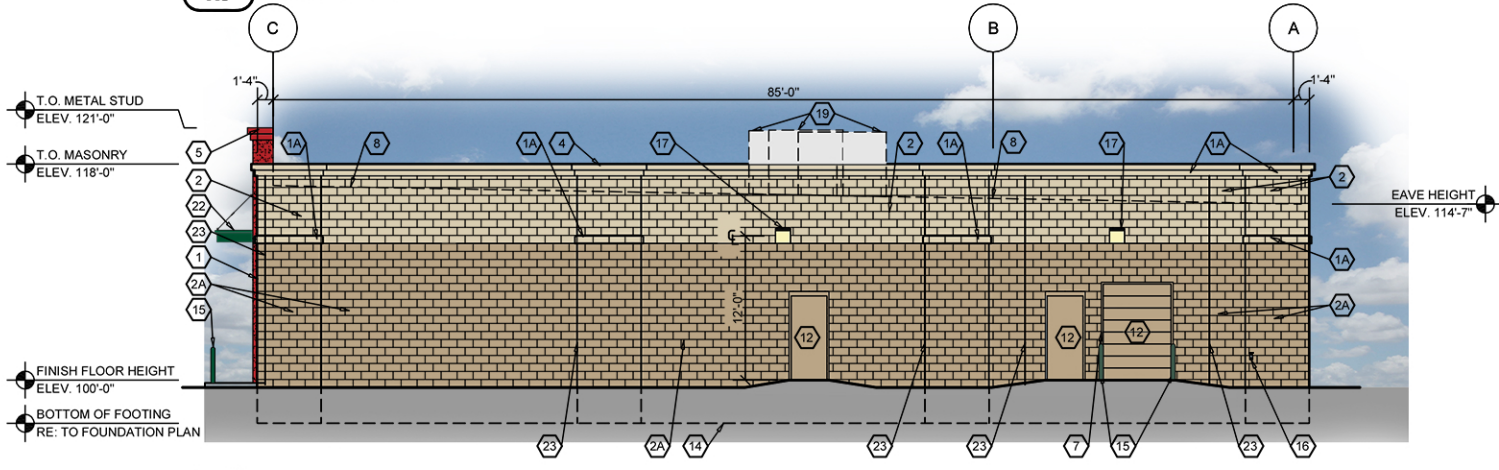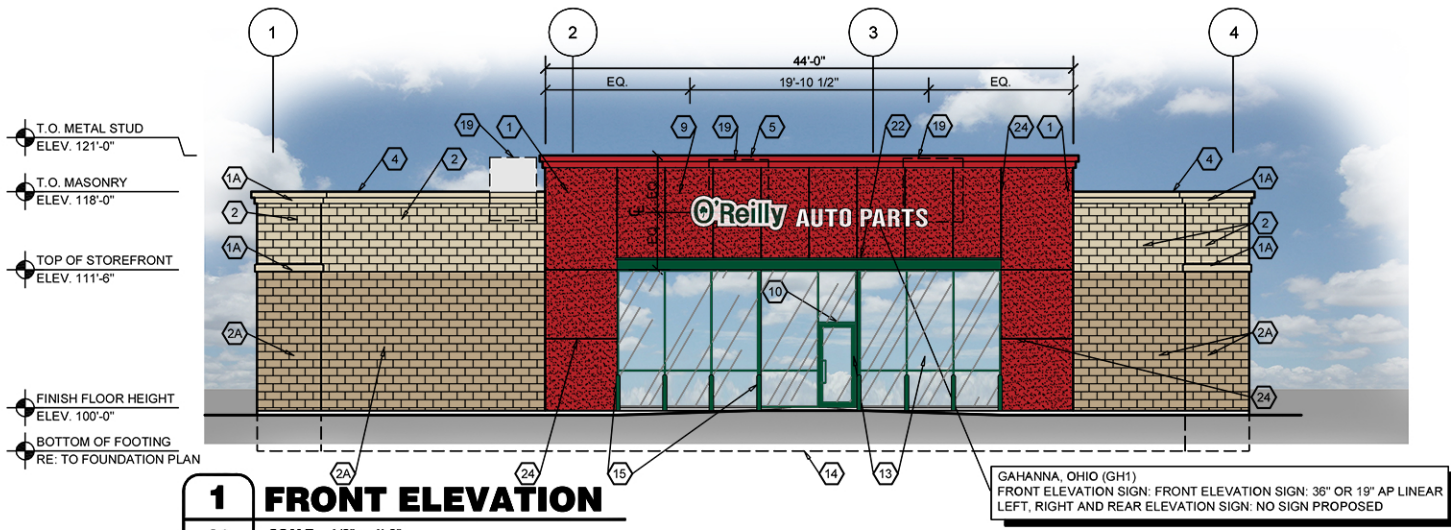

| EXTERIOR FINISH SCHEDULE                                                                                                                      |                                                                        |                                                                                                                                                                                                                                                                                                                                                                                                                                                                                                                                                                                                                           |
|-----------------------------------------------------------------------------------------------------------------------------------------------|------------------------------------------------------------------------|---------------------------------------------------------------------------------------------------------------------------------------------------------------------------------------------------------------------------------------------------------------------------------------------------------------------------------------------------------------------------------------------------------------------------------------------------------------------------------------------------------------------------------------------------------------------------------------------------------------------------|
| TYPE:                                                                                                                                         | COMPANY TYPE:                                                          | COLOR:                                                                                                                                                                                                                                                                                                                                                                                                                                                                                                                                                                                                                    |
| STANDARD CONCRETE MASONRY UNIT (C.M.U.)<br><br>SPLIT FACE (8" X 8" X 16" NOM.)<br>*PROVIDE FULL 8" FACE AT ALL CORNERS<br><br>COURSE: RUNNING | PER LOCAL SUPPLIER                                                     | SHERWIN WILLIAMS PAINT<br>(1) COAT S-W PREPRITE BLOCK FILLER B25W25 (NO LESS THAN 8 MILS)<br>(2) COATS S-W CONFLEX XL SMOOTH ELASTOMERIC A5-400 (NO LESS THAN 5.7 MILS EACH COAT)<br><br>COLD WEATHER APPLICATIONS:<br>SHERWIN WILLIAMS PAINT<br>(1) COAT S-W LOXON BLOCK SURFACER (NO LESS THAN 8 MILS)<br>(2) COATS S-W ULTRACRETE SOLVENT BORNE SMOOTH B46 (NO LESS THAN 8 MILS EACH COAT OR 16 MILS TOTAL)<br><br>ACCENT COLOR: EQUAL TO SOFTER TAN SW 6141<br><br>FIELD COLOR: EQUAL TO LATTE SW 6108 (INDICATED BY SHADING:  ) |
| EXTERIOR INSULATION AND FINISH SYSTEM (E.I.F.S.)                                                                                              | DRYVIT - OUTSULATION PLUS MD SANDBLAST FINISH                          | SW 6871 POSITIVE RED ORAP011030S WITH DRYVIT STRATOTONE HIGH PERFORMANCE COLORANT (FACTORY MIXED ONLY)                                                                                                                                                                                                                                                                                                                                                                                                                                                                                                                    |
| STOREFRONT (NO SUBSTITUTES)                                                                                                                   | EFCO                                                                   | IVY                                                                                                                                                                                                                                                                                                                                                                                                                                                                                                                                                                                                                       |
|                                                                                                                                               | KAWNEER                                                                | DARK IVY                                                                                                                                                                                                                                                                                                                                                                                                                                                                                                                                                                                                                  |
|                                                                                                                                               | VISTA WALL                                                             | INTERSTATE GREEN                                                                                                                                                                                                                                                                                                                                                                                                                                                                                                                                                                                                          |
| BOLLARDS                                                                                                                                      | IN FIELD                                                               | SHERWIN WILLIAMS SW 6468 HUNT CLUB EXTERIOR SEMI-GLOSS LATEX                                                                                                                                                                                                                                                                                                                                                                                                                                                                                                                                                              |
| EXTERIOR DOORS OVERHEAD DOOR                                                                                                                  | IN FIELD                                                               | FACTORY PRIME FIELD PAINTED SW 6108 LATTE                                                                                                                                                                                                                                                                                                                                                                                                                                                                                                                                                                                 |
| SHEET METAL CAP FLASHING AT E.I.F.S.                                                                                                          | BY METAL BUILDING MFG'R<br>FIELD BROKEN<br>FACTORY PRIME FIELD PAINTED | SHERWIN WILLIAMS SW 6871 POSITIVE RED (VERIFY MIX BELOW MATCHES E.I.F.S. COLOR)<br>CLEAR COAT-DIAMOND CLAD CLEAR COAT URETHANE B65T105/B65V105/B65C105--3 COMPONENT                                                                                                                                                                                                                                                                                                                                                                                                                                                       |
| PRE - FINISHED SHEET METAL CAP FLASHING                                                                                                       | BY METAL BUILDING MFG'R<br>FIELD BROKEN                                | COOL BIRCH WHITE                                                                                                                                                                                                                                                                                                                                                                                                                                                                                                                                                                                                          |
| SHEET METAL CONDUCTOR HEADS AND DOWNSPOUT                                                                                                     | PER LOCAL SUPPLIER                                                     | PRE-FINISHED MATCH SHERWIN WILLIAMS "LATTE" SW 6108                                                                                                                                                                                                                                                                                                                                                                                                                                                                                                                                                                       |
| EXTERIOR INSULATION AND FINISH SYSTEM (E.I.F.S.) ACCENT BAND                                                                                  | DRYVIT - OUTSULATION PLUS MD SANDBLAST FINISH                          | SHERWIN WILLIAMS COLOR: SW 6141 "SOFTER TAN"                                                                                                                                                                                                                                                                                                                                                                                                                                                                                                                                                                              |
| PREFABRICATED METAL CANOPY                                                                                                                    | PER LOCAL SUPPLIER                                                     | POWDER COATED (MATCH SW 6468 "HUNT CLUB")                                                                                                                                                                                                                                                                                                                                                                                                                                                                                                                                                                                 |